
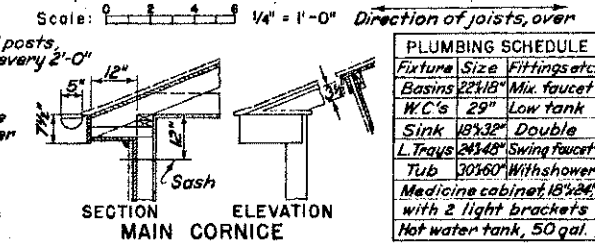
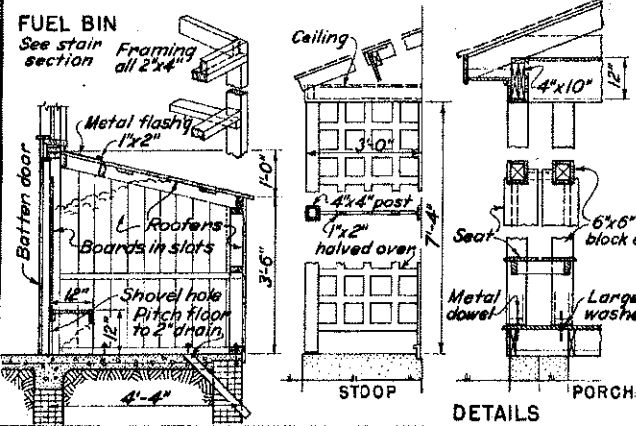


For masonry exterior walls, substitute EX.7031 for sheet 4.

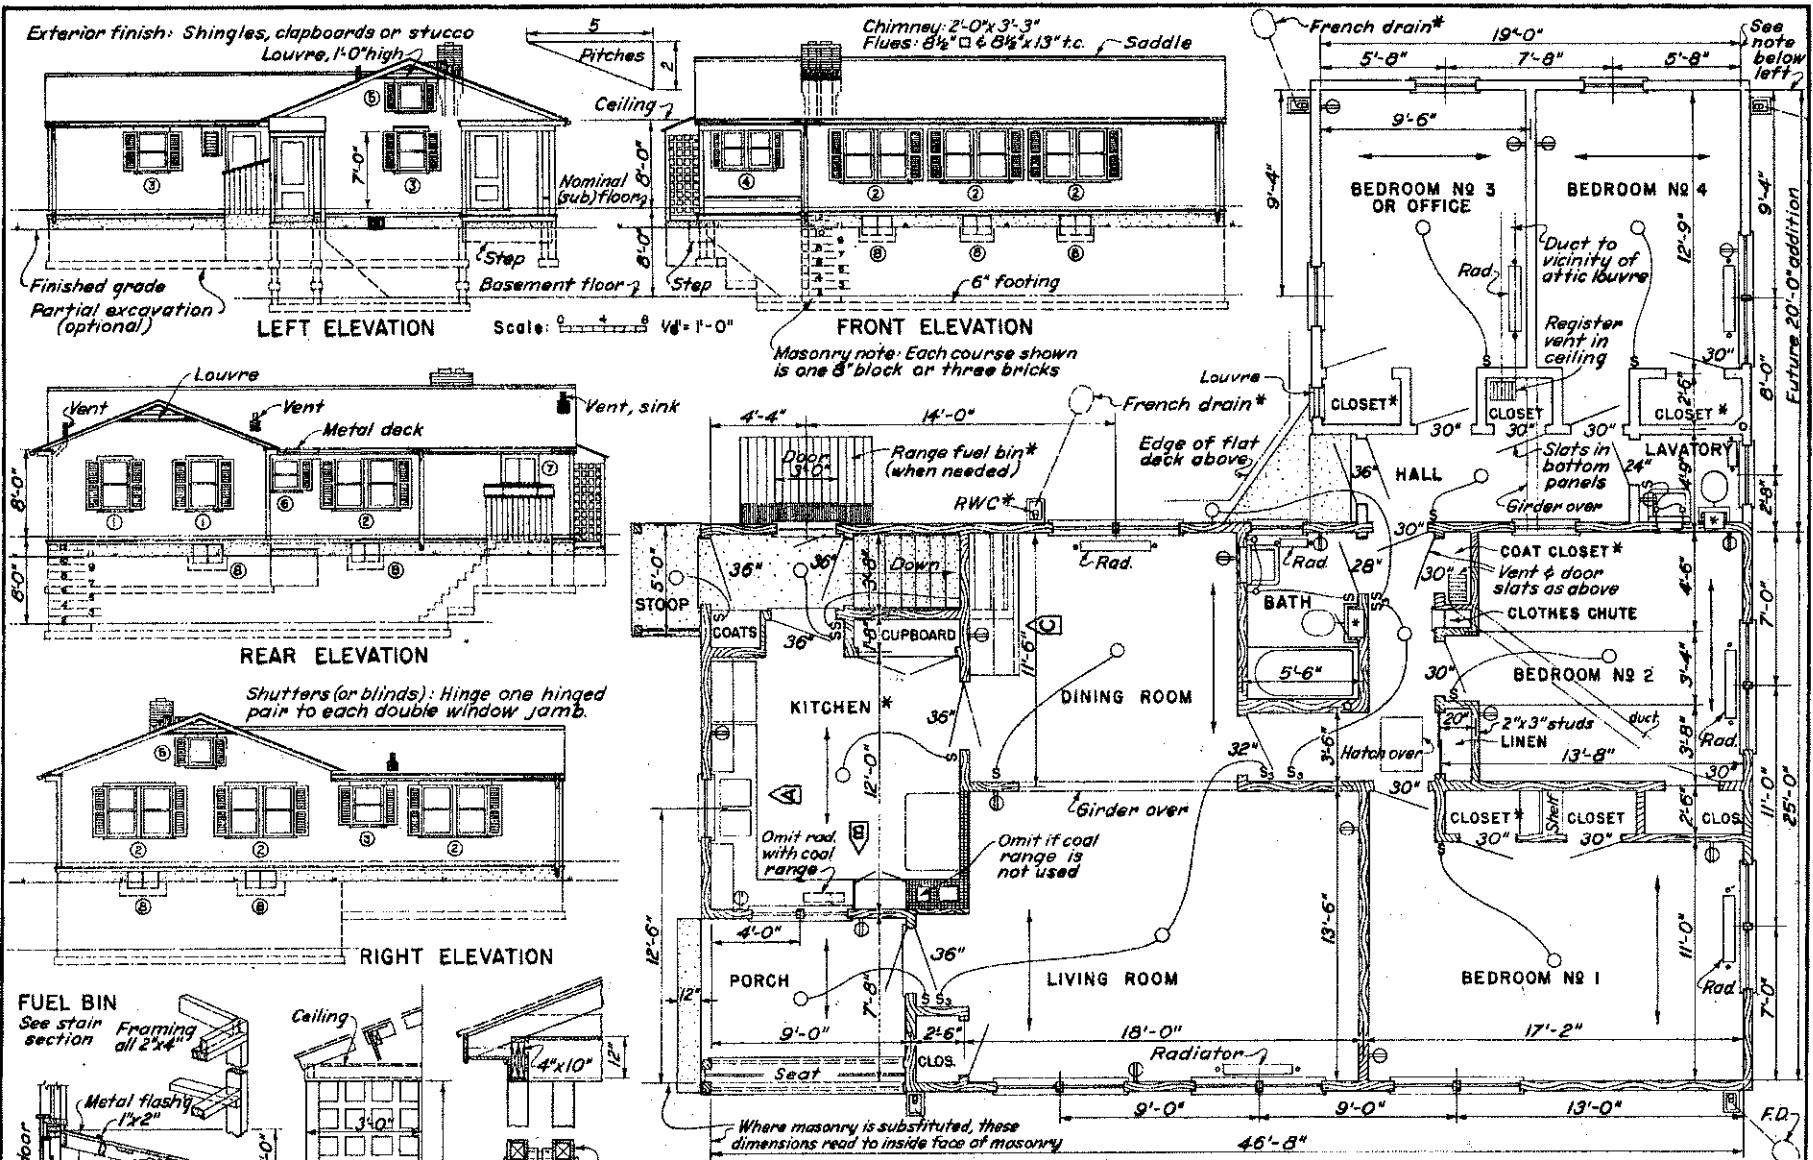

PLUMBING SCHEDULE  
 Fixture Size Fittings etc.  
 Basins 22 1/8" Mix. faucet  
 W.C.'s 29" Low tank  
 Sink 18 3/8" Double  
 L. Trays 24 1/2" Swing faucet  
 Tub 30 3/8" With shower  
 Medicine cabinet 18 1/2" x 24" with 2 light brackets  
 Hot water tank, 50 gal.

WINDOW SCHEDULE \*  
 No. Wide High Notes  
 ① 2'-8" 4'-6" Double  
 ② " " " Double  
 ③ " " 3'-6" Double  
 ④ 2'-0" " Double  
 ⑤ 2'-4" 2'-6" Casem't  
 ⑥ " " 2'-10" Casem't  
 ⑦ 3'-1" 2'-2" Casem't  
 ⑧ 2'-8" 1'-10" Steel


\* SEE DETAILS, sheets 3 & 4 elsewhere

COOPERATIVE EXTENSION WORK IN AGRICULTURE AND HOME ECONOMICS  
 STATE OF IOWA  
 PURDUE UNIVERSITY  
 AND  
 UNITED STATES DEPARTMENT OF AGRICULTURE COOPERATING



**FARMHOUSE PLAN**

USDA 47 EX. 7014 SHEET 1 OF 4


STATE OF NORTH DAKOTA  
 NORTH DAKOTA STATE UNIVERSITY  
 OF AGRICULTURE AND APPLIED SCIENCE

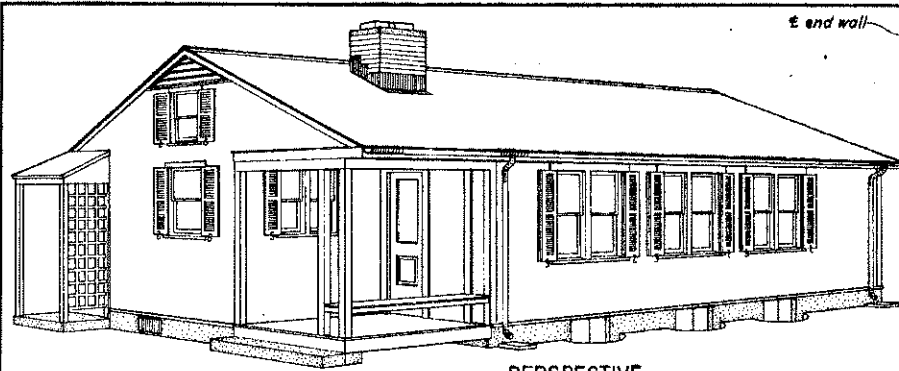


PERSPECTIVE

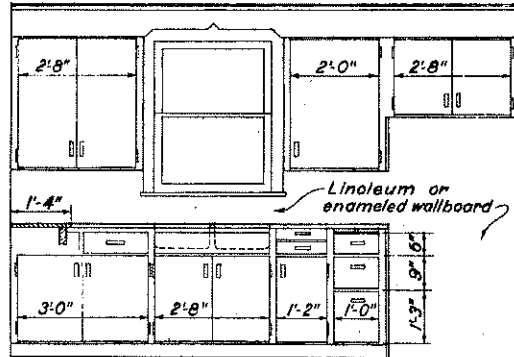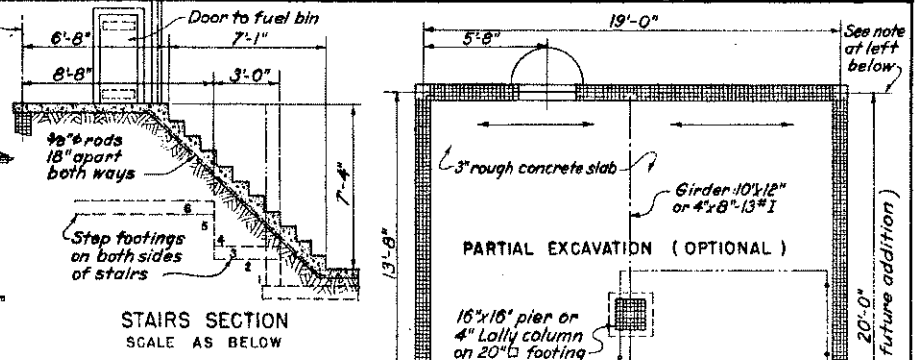

A

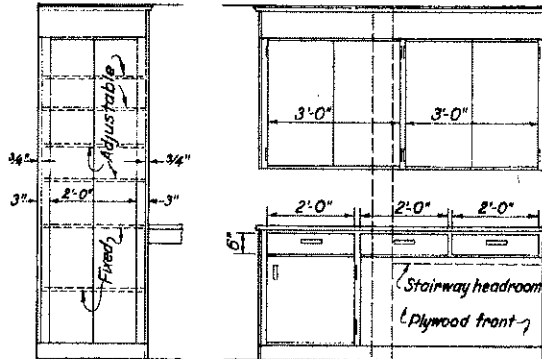


KITCHEN ELEVATIONS\* C

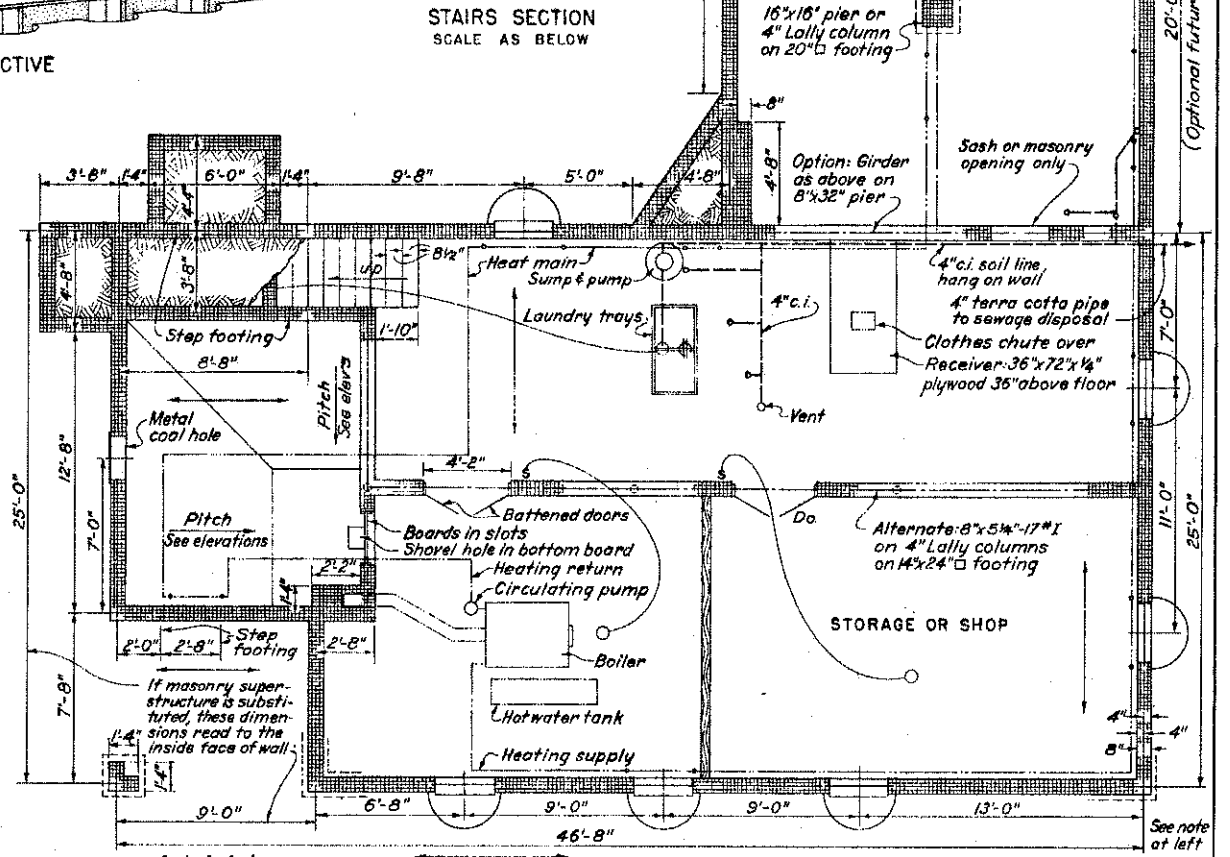


SCALE 1/4" = 1'-0"

Direction of joists, over\*

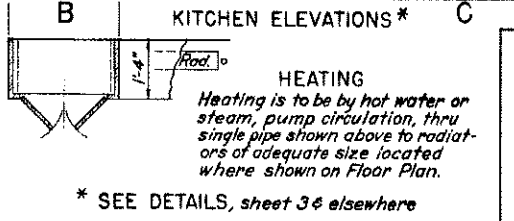

\* SEE DETAILS, sheet 36 elsewhere

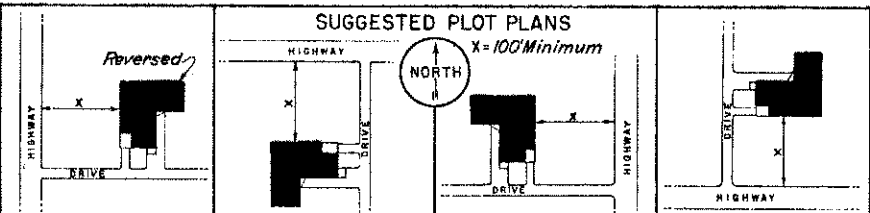

COOPERATIVE EXTENSION WORK IN AGRICULTURE AND HOME ECONOMICS

FUTURE UNIVERSITY BUILDING

AND

UNITED STATES DEPARTMENT OF AGRICULTURE COOPERATING

**FARMHOUSE PLAN**

USDA '47 EXL 7014 SHEET 2 OF 4

**SYMBOLS USED ON DRAWINGS IN THIS SET**

**STRUCTURAL**  
 Work above plan or this (near) side of Section.  
 " below " other (far) "  
 \*SEE DETAILS: For more directions on detail sheets or on plan sheets.  
 Dada, Ditto: Same as shown directly above or at left.


**PLAN**  
 [Symbol] Optional Masonry, Brick, Block, Tile, Concrete.  
 [Symbol] Frame Walls & Partitions.  
 [Symbol] Metal Casements, [Symbol] Double Hung Window.

**SECTION**  
 [Symbol] Wood, [Symbol] Masonry, [Symbol] Concrete, [Symbol] Earths.  
 [Symbol] Insulations, T.C.F.L. Terra Cotta Flue Lining, [Symbol] Center Line.


**ELECTRICAL**  
 [Symbol] Ceiling Light, [Symbol] Convenience Outlet, [Symbol] Switch, [Symbol] 3 Way.

**HEATING**  
 [Symbol] Warm Air Register, [Symbol] Air Return, Wall, [Symbol] Floor, [Symbol] Riser Duct.



**INTERIOR DOOR TRIM & BASEBOARD**

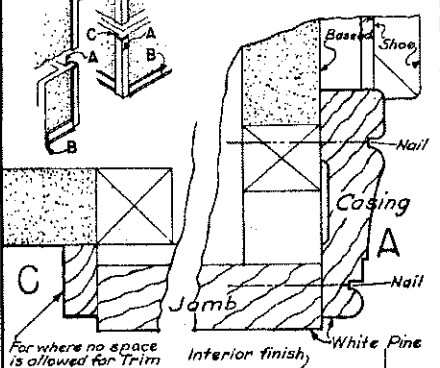



**INTERIOR DOORS**

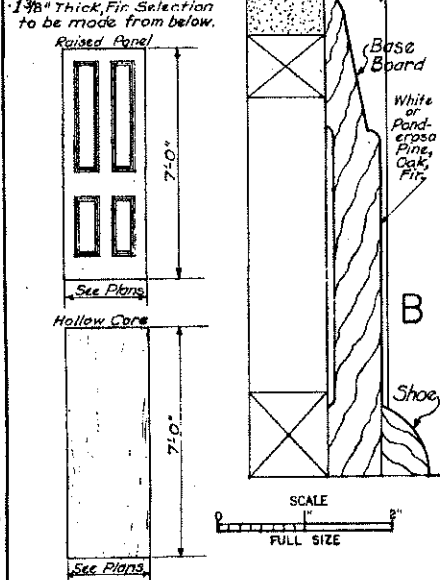



**WINDOW TRIM**

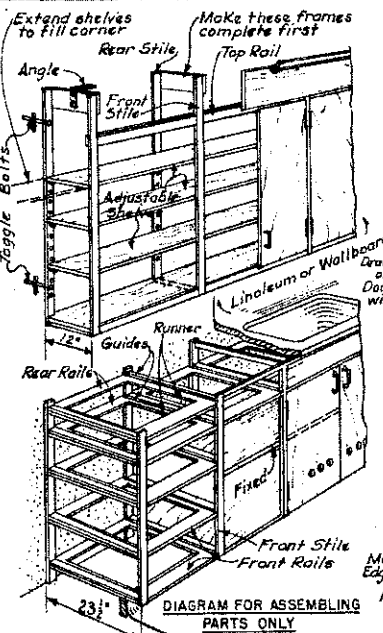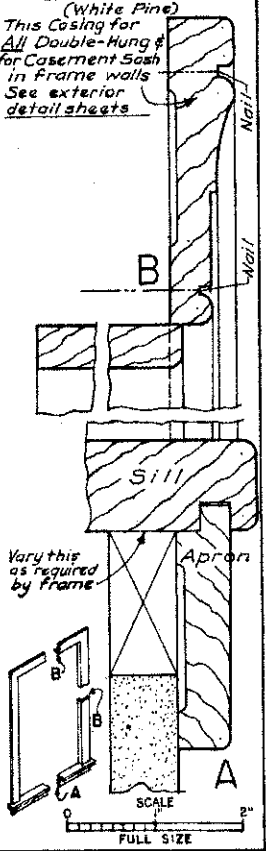




**KITCHEN CABINET DETAILS**

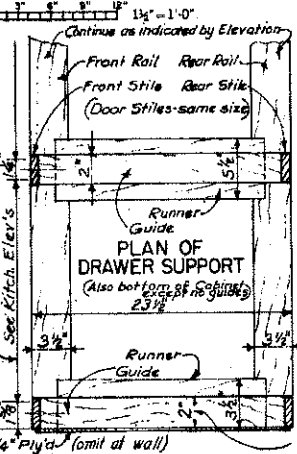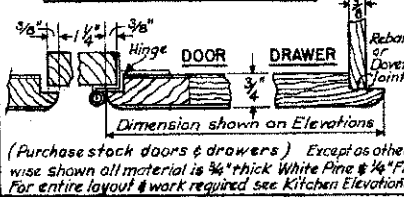

**BASE CABINET SINK & CUPBOARDS**

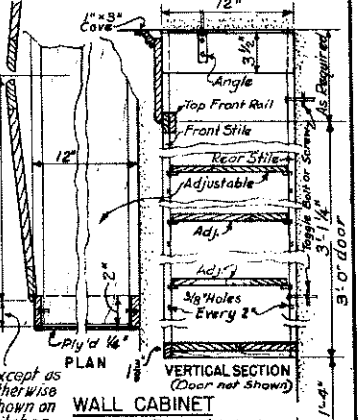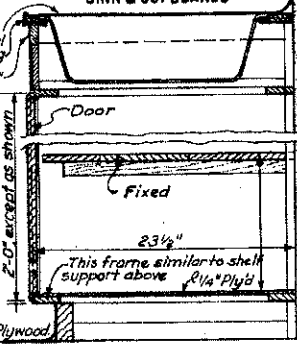


**BASE CABINET DRAWERS**

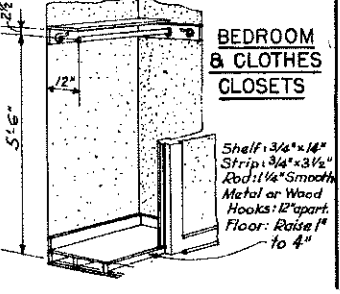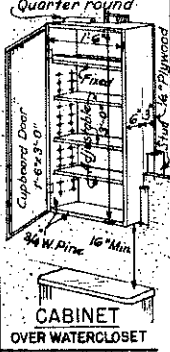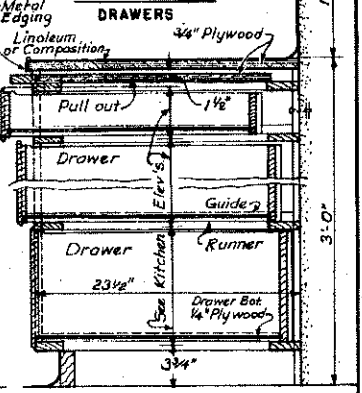

COOPERATIVE EXTENSION WORK IN AGRICULTURE AND HOME ECONOMICS  
 STATE OF NORTH DAKOTA  
 PURDUE UNIVERSITY  
 AND  
 UNITED STATES DEPARTMENT OF AGRICULTURE COOPERATING


**FARMHOUSE PLAN**

U.S.D.A. '47 EX. 7014 SHEET 3 OF 4

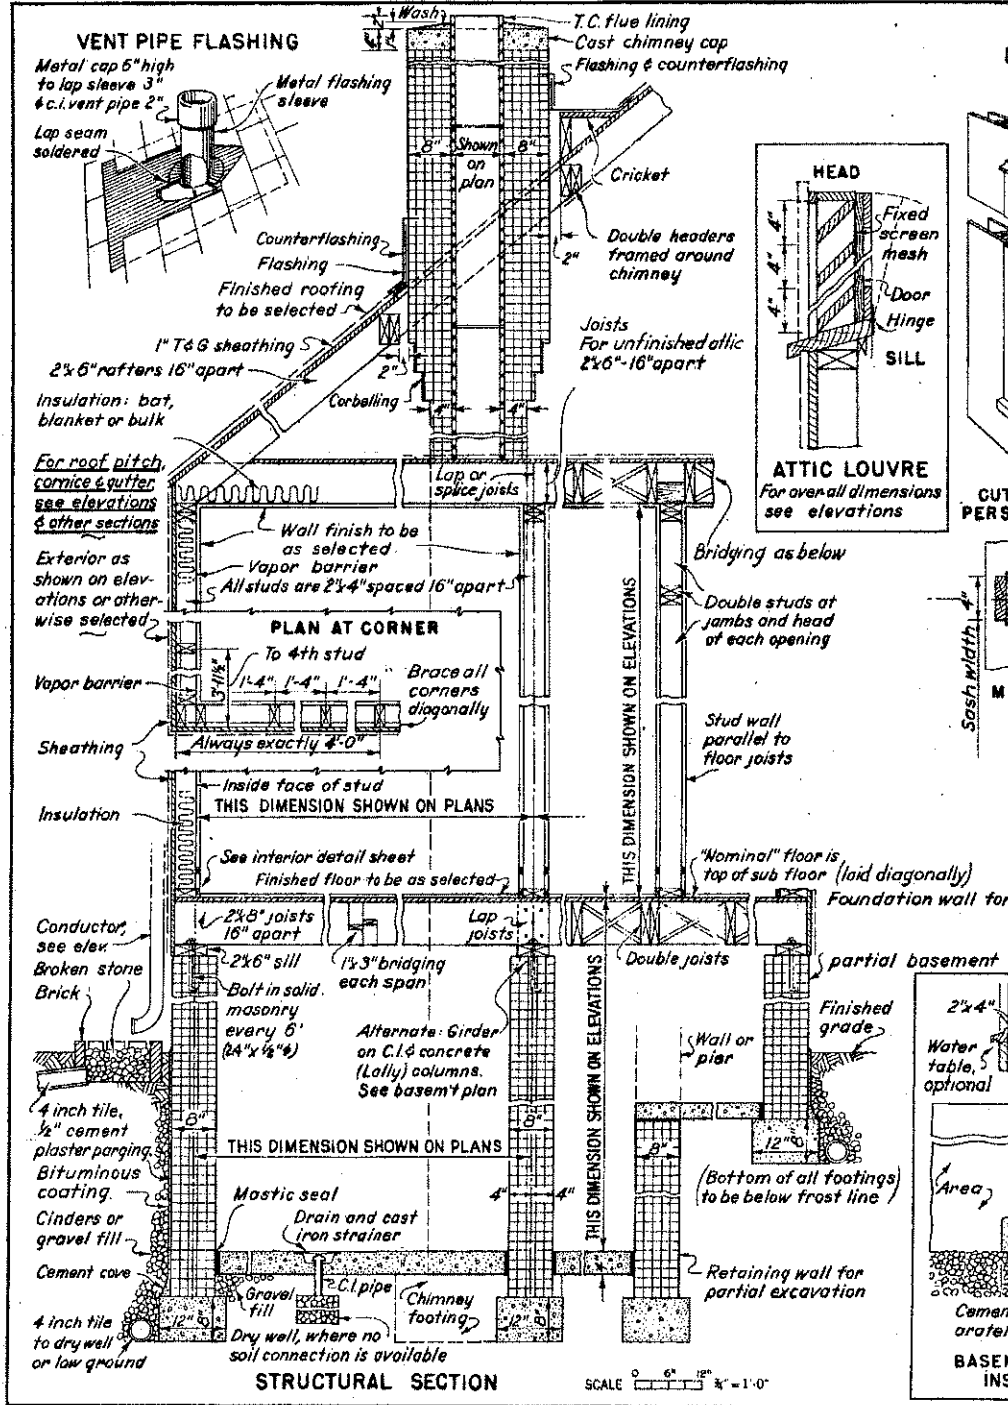


### DOUBLE HUNG WINDOWS

Where shown on plans & elevations or otherwise selected

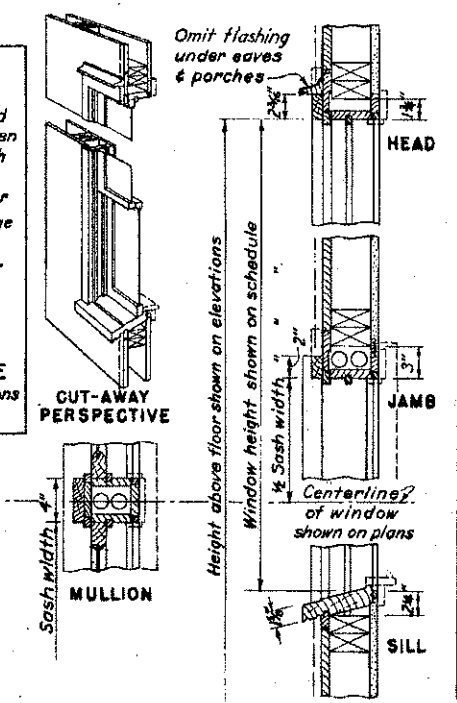

### METAL CASEMENT WINDOWS

Where shown on plans & elevations or otherwise selected


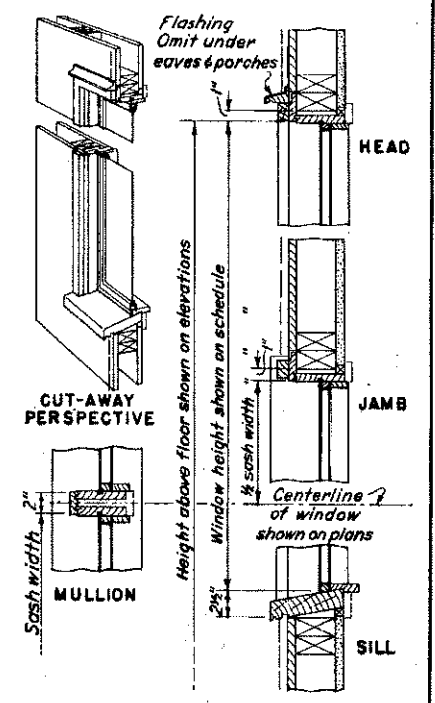


For interior trim of windows see interior detail sheet

For exposed doors apply flashed drip cap at head

NOTE: Sash are to be delivered with the wood head, jamb & sill parts shown, applied by manufacturer (packaged window) ready to install in framing

**WINDOW & DOOR DETAILS**  
SCALE 0 3" 6" 9" 12" 1 1/2" = 1'-0"

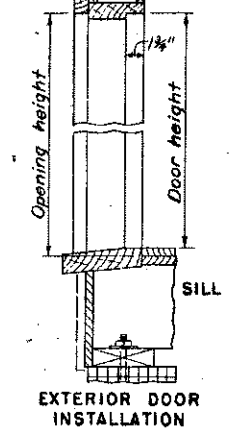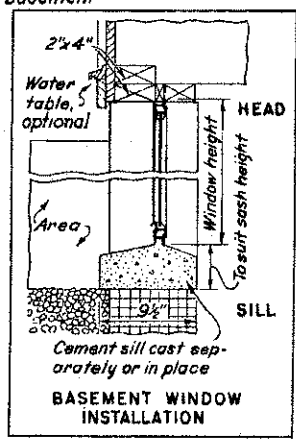

**GENERAL NOTES**

If masonry walls are substituted for frame, replace this drawing with EX. 7031

COOPERATIVE EXTENSION WORK IN AGRICULTURE AND HOME ECONOMICS  
STATE OF INDIANA  
PURDUE UNIVERSITY  
AND  
UNITED STATES DEPARTMENT OF AGRICULTURE, COOPERATIVE

**FARMHOUSE PLAN**

U.S.D.A. '47 EA. 7014 SHEET 4 OF 4