

FLOOR PLAN

SCALE
1" = 2'-0"



DOOR SCHEDULE		
MARK	SIZE	DESCRIPTION
1	3-0" x 6-8"	SOLID CORE-GLAZED
2	3-0" x 6-8"	ALUM. SCREENED
3	6-0" x 6-8"	WOOD BIFOLD
4	2-0" x 6-8"	SLIDING
5	2-0" x 6-8"	HOLLOW CORE-INT.
6	3-0" x 6-8"	SLIDING - POCKET
7	5-0" x 6-8"	WOOD BIFOLD
8	4-0" x 6-8"	WOOD BIFOLD
9	3-0" x 6-8"	HOLLOW CORE-INT.
10	3-0" x 6-8"	FOLDING
11	3-0" x 6-8"	SOLID CORE-EXT.
12	2-6" x 6-8"	HOLLOW CORE-INT.

WINDOW SCHEDULE		
MARK	SIZE	DESCRIPTION
A	3-8" x 4-4"	ALUMINUM-DOUBLE HUNG
B	3-4" x 3-4"	ALUMINUM-DOUBLE HUNG
C	2-0" x 3-2"	ALUMINUM-DOUBLE HUNG
D	2-8" x 4-4"	ALUMINUM-DOUB. E HUNG

NOTES:
 BASIC ELECTRICAL PLAN(SHEET 3)
 REFLECTS ALTERNATE FLOOR PLAN.
 CONSULT LOCAL BUILDING
 CODES AND AUTHORITIES
 BEFORE BEGINNING ANY
 TYPE OF CONSTRUCTION




NOTE:
 EXTERIOR DIMENSIONS TO
 OUTSIDE FACE OF STUDS.
 * OPTIONAL EXERCISE ROOM
 SEE SHEET 4

COOPERATIVE EXTENSION WORK IN
 AGRICULTURE AND HOME ECONOMICS


UNIVERSITY OF ARKANSAS
 AND
 UNITED STATES DEPARTMENT OF AGRICULTURE COOPERATING

THREE BEDROOM HOUSE
 FOR THE HANDICAPPED
 USDA '77 7216 SHEET 1 OF 4
 REVISED 6/83

BASED ON UNIV. OF ARK. PLAN NC 747601

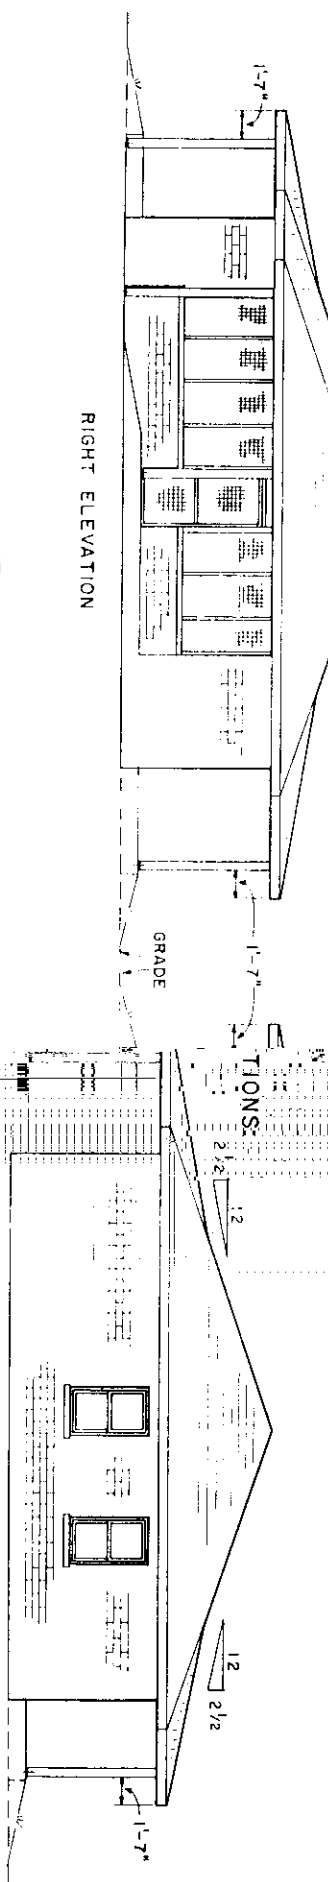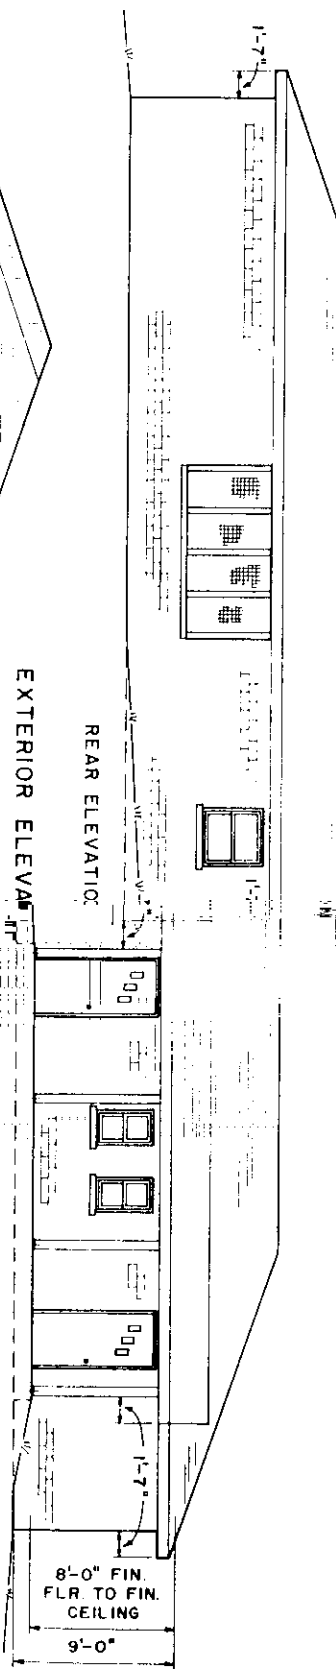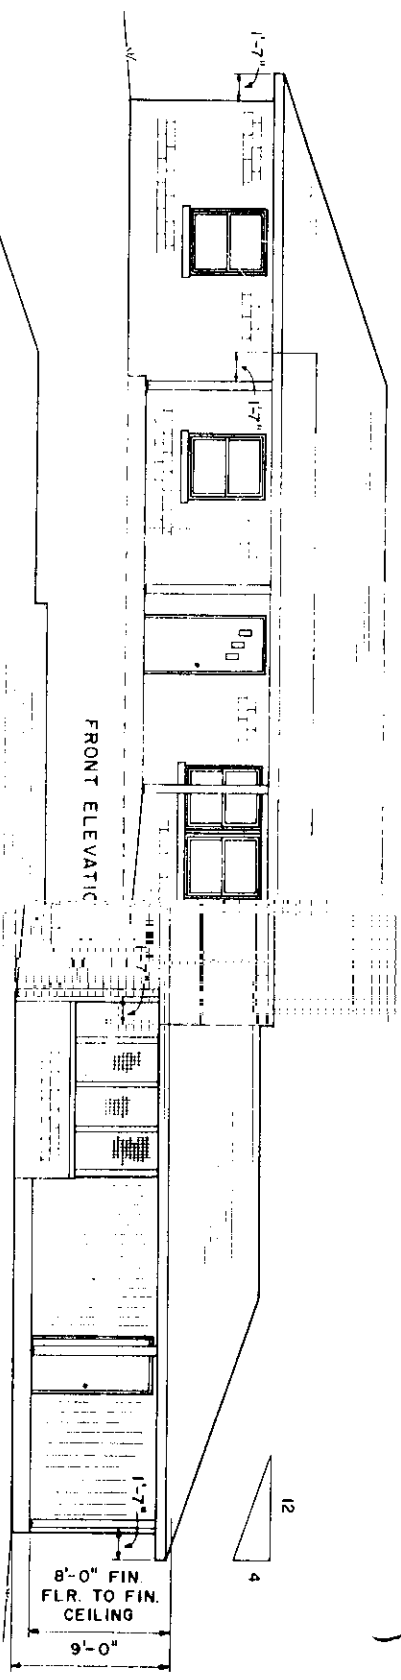

KITCHEN INTERIOR ELEVATIONS

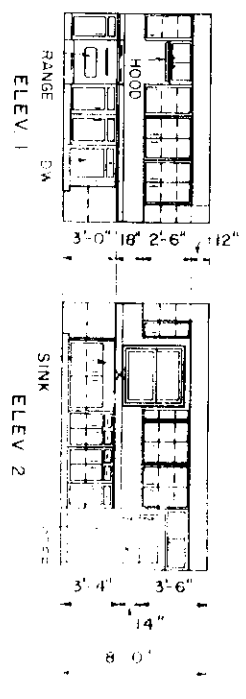





COOPERATIVE EXTENSION WORK IN
 AGRICULTURE AND HOME ECONOMICS

UNITED STATES DEPARTMENT OF AGRICULTURE COOPERATING
 AND

**THREE BEDROOM HOUSE
 FOR THE HANDICAPPED**

ELECTRICAL LEGEND	
S	SINGLE POLE SWITCH
S3	THREE WAY SWITCH
○	CEILING OUTLET
○	WALL OUTLET
○	FLUORESCENT LIGHT FIXTURE OUTLET
○	DUPLEX CONVENIENCE OUTLET
○	GROUNDING WATERPROOF OUTLET
○	GROUNDING OUTLET
○	SPECIAL PURPOSE OUTLET
○	HOSE CONNECTION
○	WALL PANEL
○	OUTLET WITH PULL CHAIN


VTR VENT THRU ROOF
 HTR HEATER
 WH WATER HEATER
 DW DISHWASHER
 DR DRYER

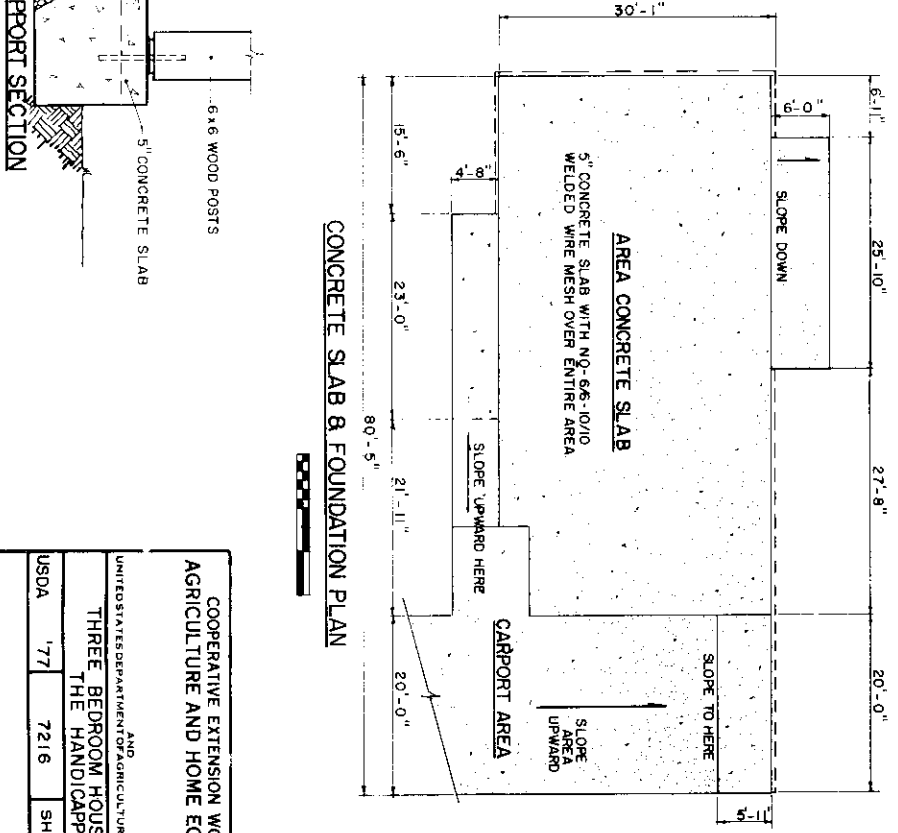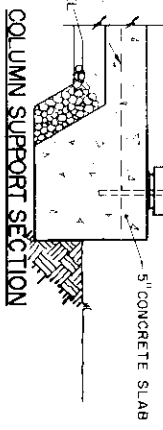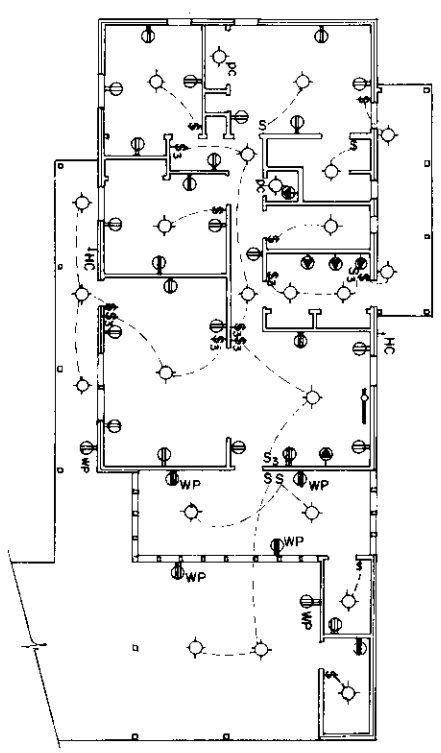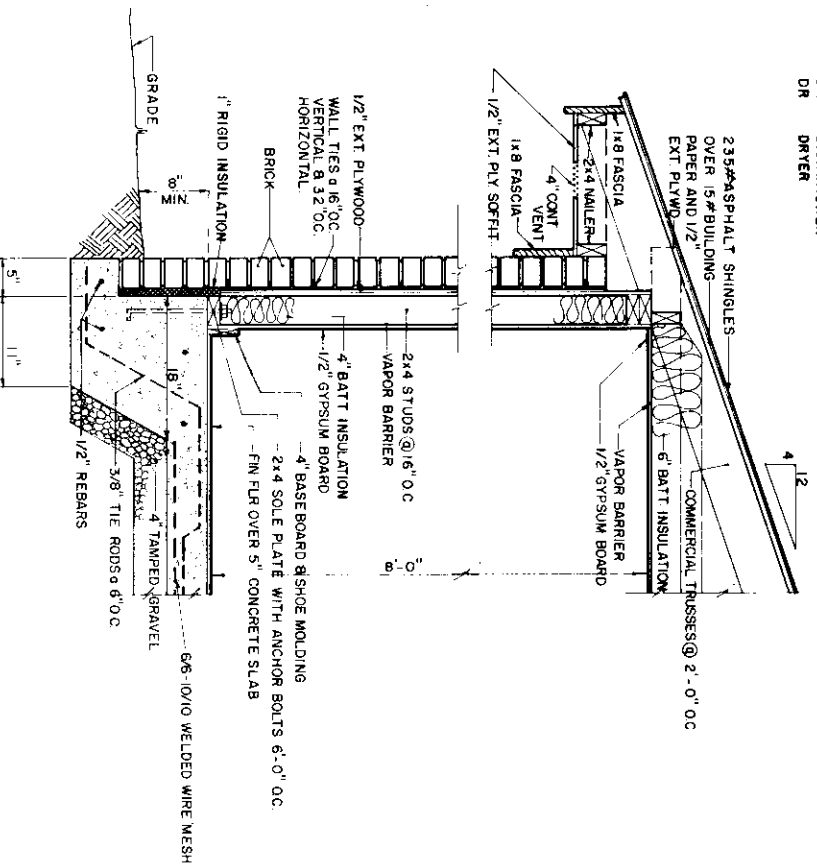


COOPERATIVE EXTENSION WORK IN
 AGRICULTURE AND HOME ECONOMICS

UNITED STATES DEPARTMENT OF AGRICULTURE COOPERATING
 AND
 THREE BEDROOM HOUSE FOR
 THE HANDICAPPED


USDA 77 7216 SHEET 3 OF 4

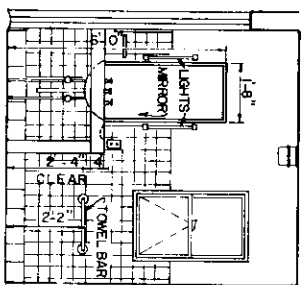


SECTION A-A

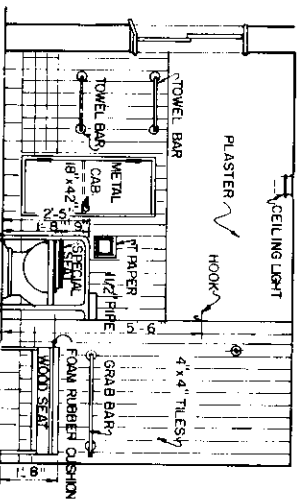


SECTION B-B
3/4" x 4" PIPE SLEEVES
FLUSH AT TOP WITH FIN F.
UPRIGHS LEANED IN

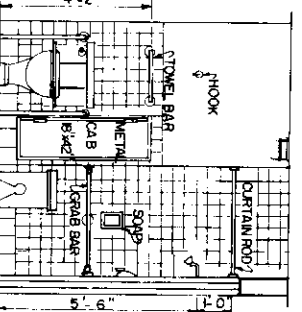


SECTION C-C

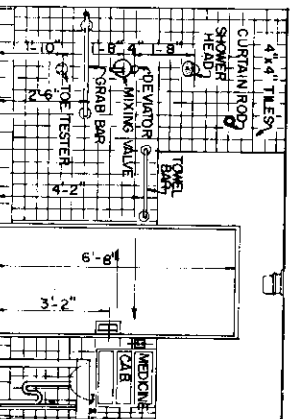


SECTION D-D

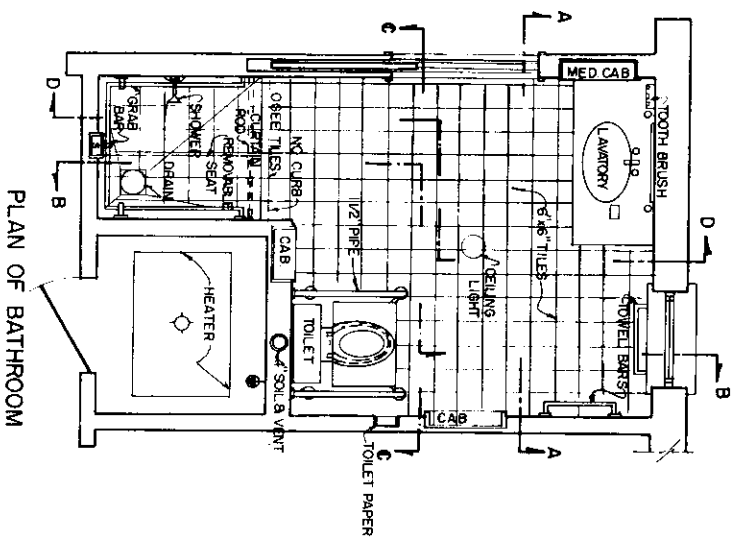


PLAN OF BATHROOM

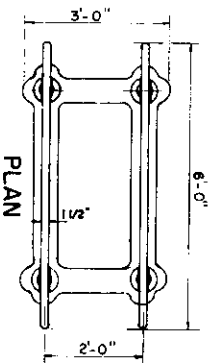


PLAN

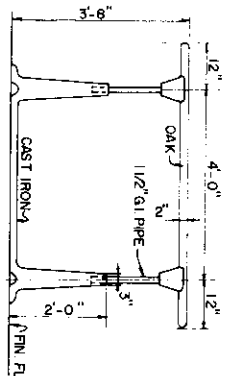

ELEVATION
PARALLEL BARS

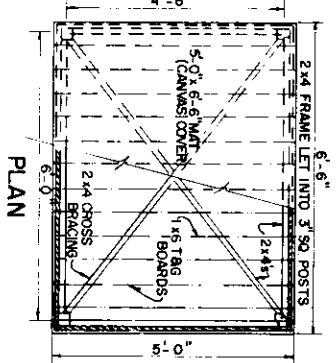

PLAN

 

ELEVATION
EXERCISE MAT

COOPERATIVE EXTENSION WORK IN
AGRICULTURE AND HOME ECONOMICS

UNITED STATES DEPARTMENT OF AGRICULTURE
AND
NATIONAL COOPERATIVE EXTENSION SERVICE
THREE BEDROOM HOUSE
FOR THE HANDICAPPED
USDA 77 7216 SHEET 4 OF 4