




LEG A - 500 BU/YR. DISK-DRIVEN WRT. CLEAN (MAIN LEG)  
 LEG B - 200 BU/YR. DISK-DRIVEN WRT. CLEAN (MAIN LEG)  
 LEG C - 500 BU/YR. DISK-DRIVEN WRT. CLEAN (MAIN LEG)  
 LEG D - 500 BU/YR. DISK-DRIVEN WRT. CLEAN (MAIN LEG)

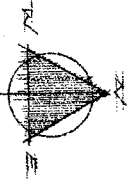

SCALE: 1/8" = 1'-0"

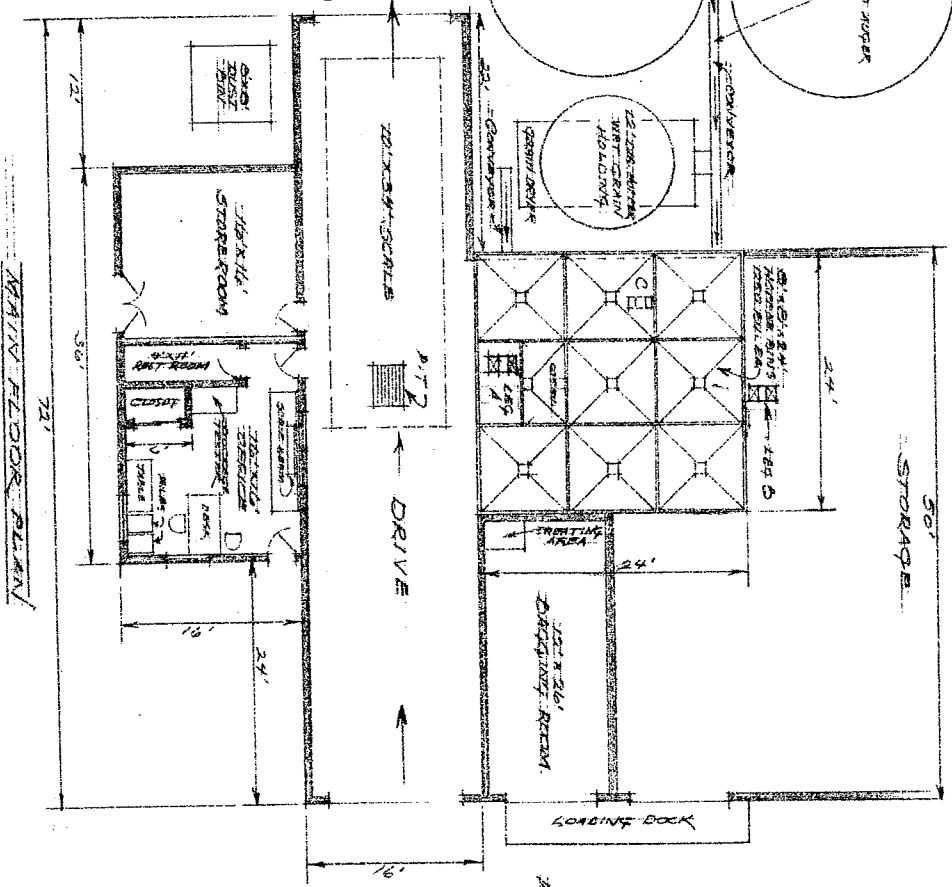


MAIN FLOOR PLAN

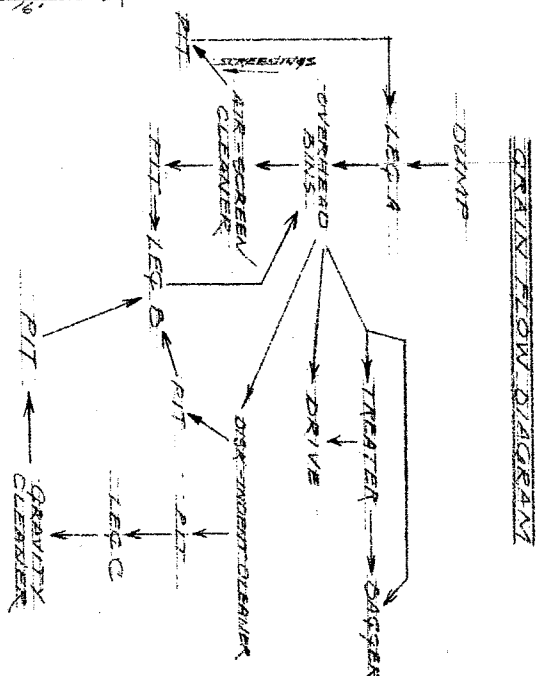

GRAIN FLOW DIAGRAM

<b>SEED CLEANING PLANT</b>	
DESIGNED FOR	SCALE
RAY KIMMORBY	1/8" = 1'
PREPARED BY	DRAWN BY
NOSA EXTENSION AG. ENG. DEPT.	R. ROBERTS
DATE	APPROVED BY
2/21/44	NO. 732-2-18
	OVERSEE NUMBER
	5/17 1052

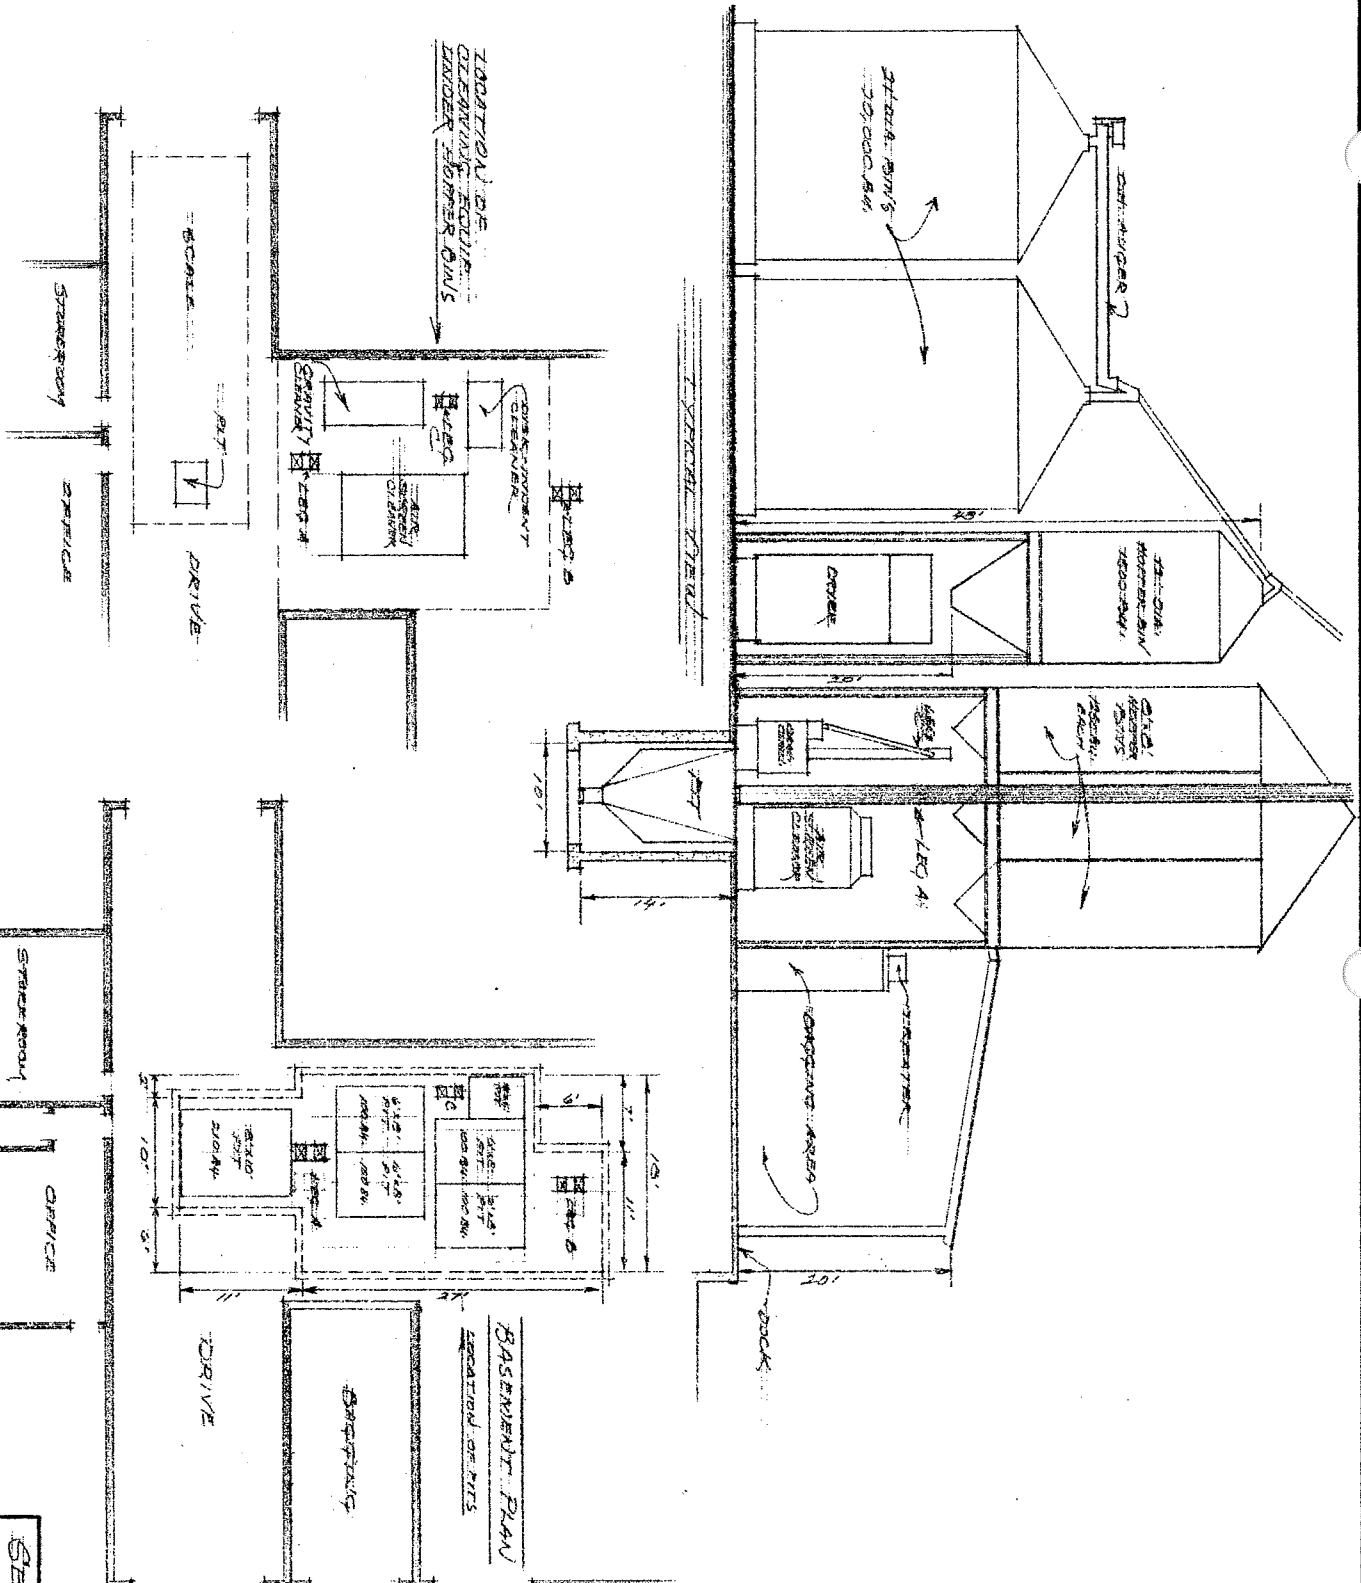

SEED CLEANING PLANT	
PREPARED FOR RAY KINNDORF	SCALE AS SHOWN
PREPARED BY NOSTI-EXTENSIONAL HOUS. ENGR. DEPT.	DRAWN BY R. S. S. S.
DATE 2/24/54	REVISIONS BY R. S. S. S.
APPROVED BY N.D. 732-2-48	DRAWING NUMBER 247