
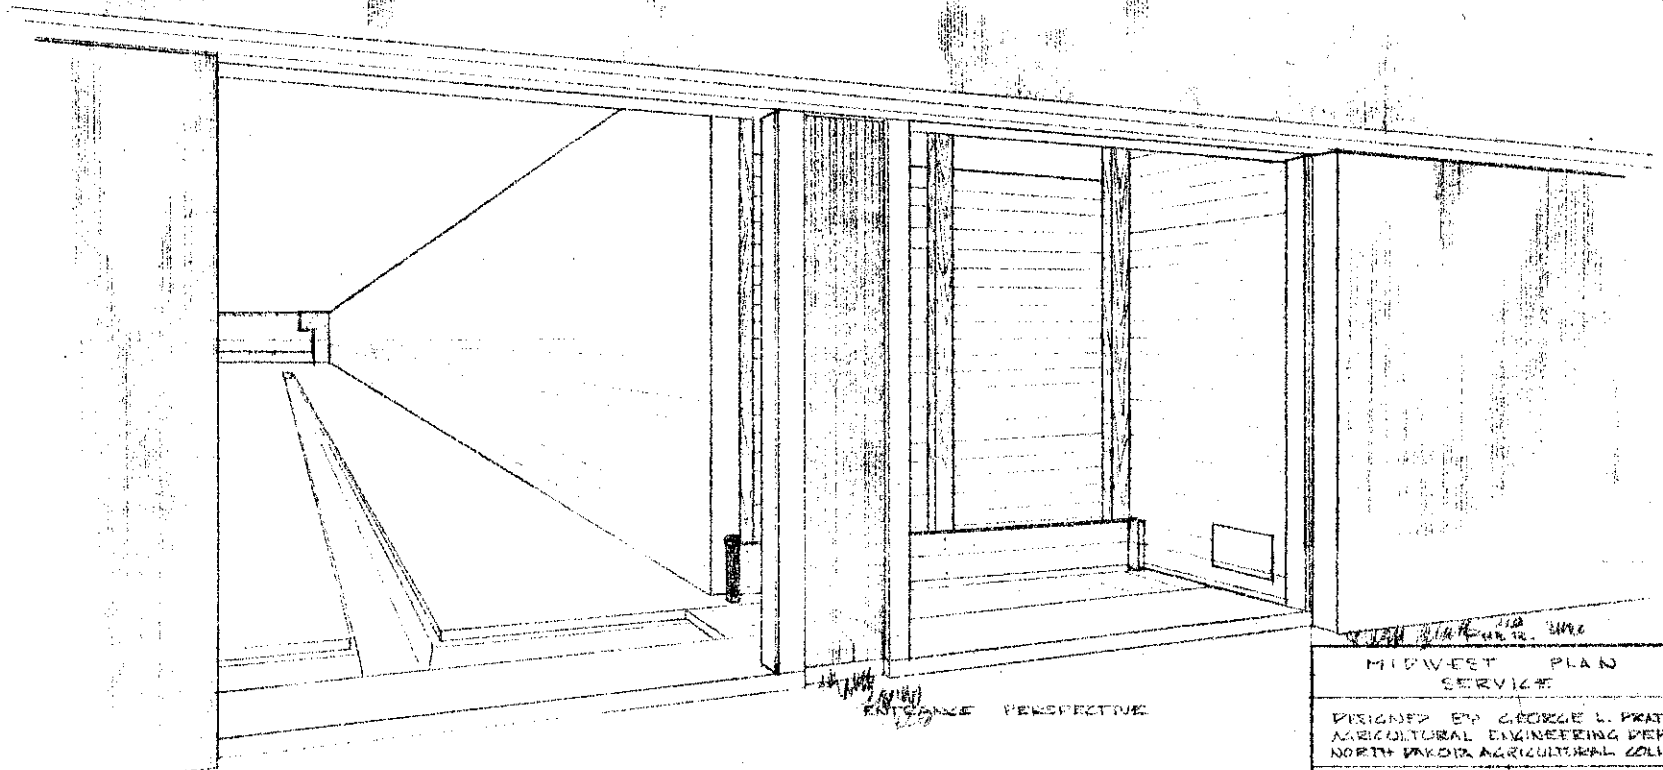


100,000 BUSHEL POTATO WAREHOUSE

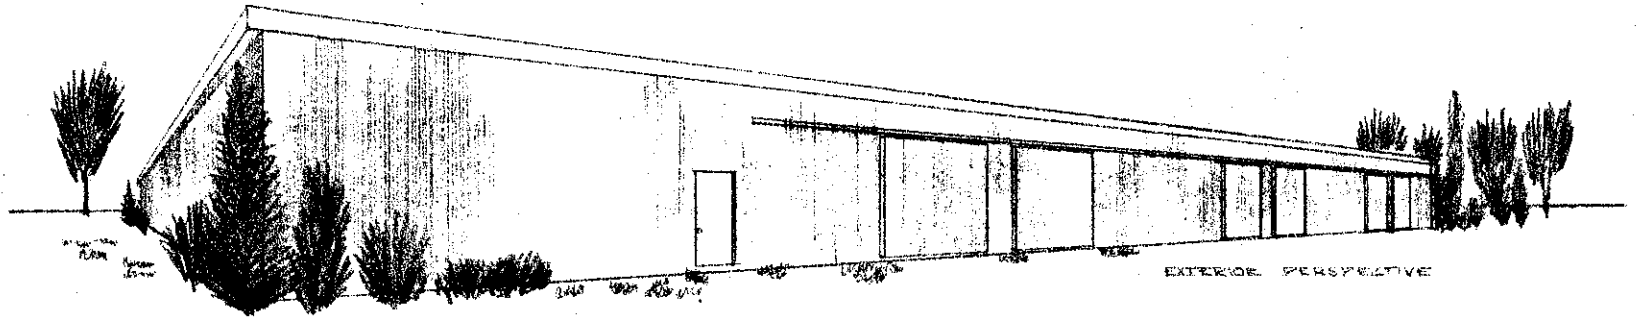





MIDWEST PLAN SERVICE

DESIGNED BY GEORGE L. PRATT  
AGRICULTURAL ENGINEERING DEPT.  
NORTH DAKOTA AGRICULTURAL COLL.

JULY 1960

SHEET 1 of 4

ND 734-6-4

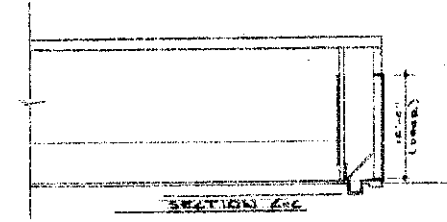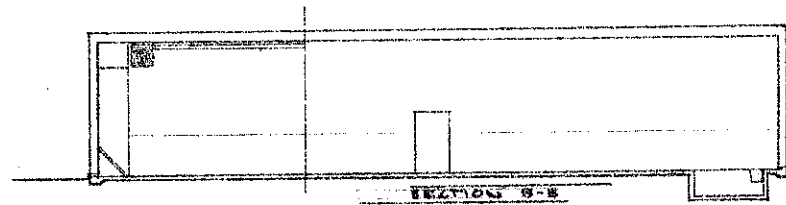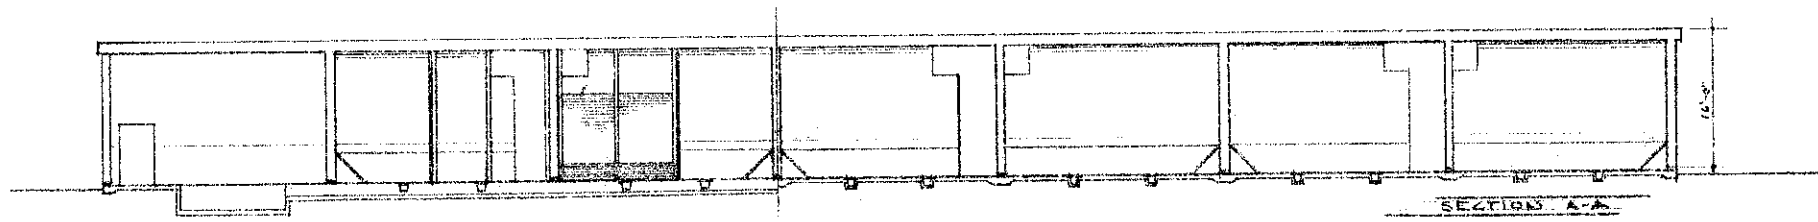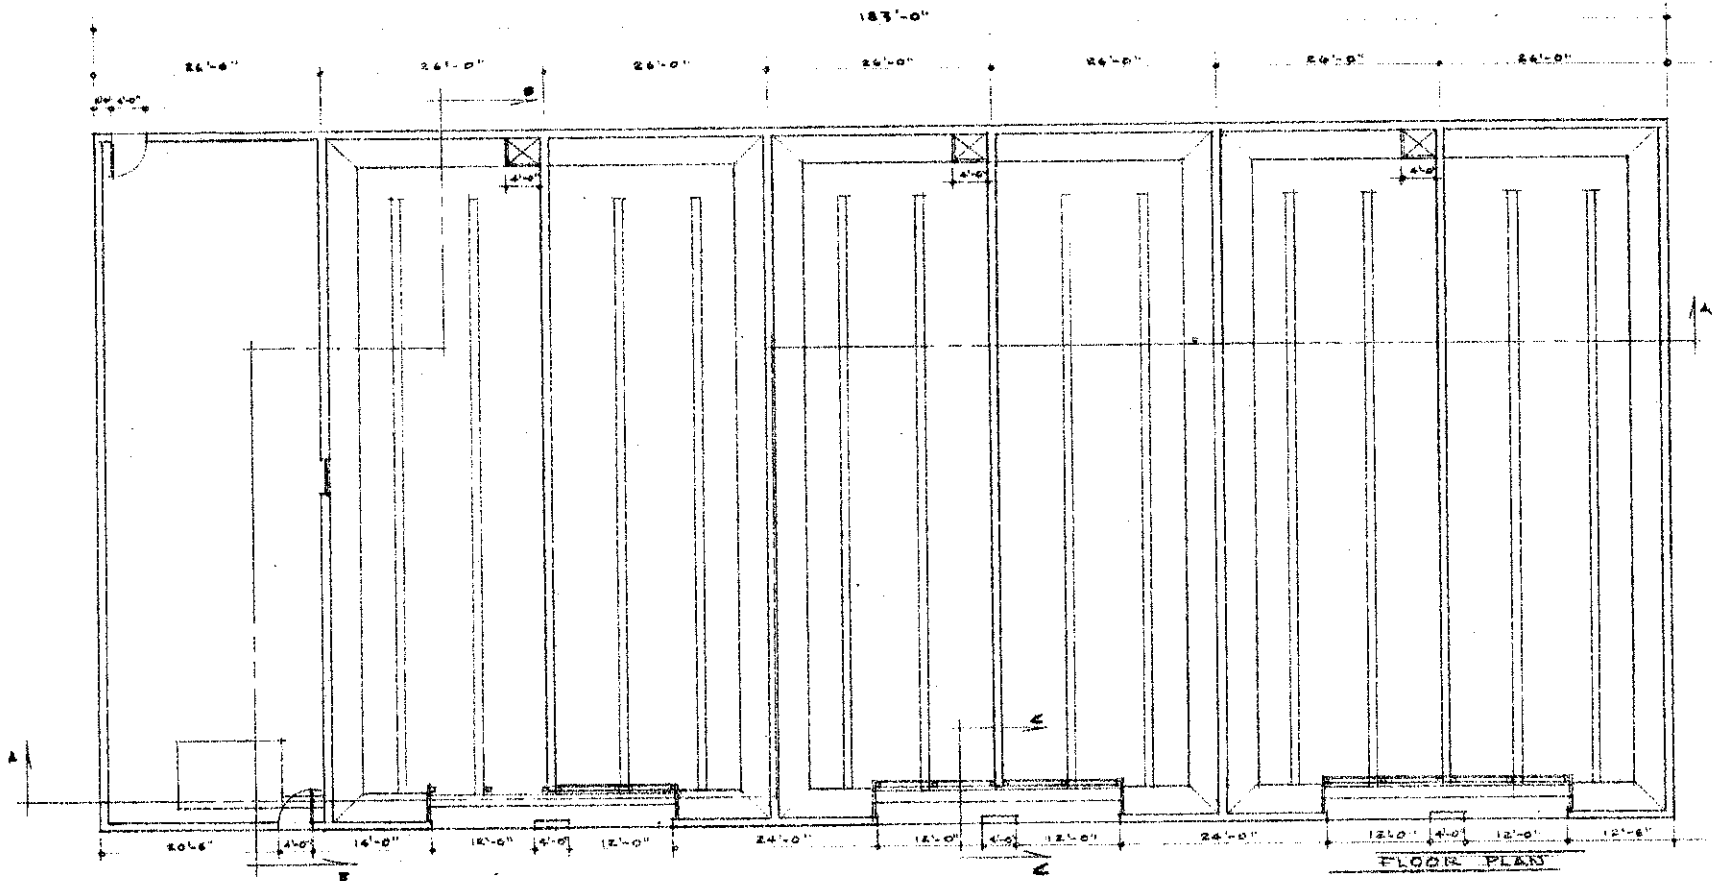


SCALE - 3/32" = 1'-0"


100,000 BUSHEL POTATO WAREHOUSE	
MIDWEST PLAN SERVICE	
DESIGNED BY GEORGE L. EBBETT AGRICULTURAL ENGINEERING DEPT. NORTH DAKOTA AGRICULTURAL COLL.	
JULY 1960	SHEET 2 OF 4

N.D. 728-6-4




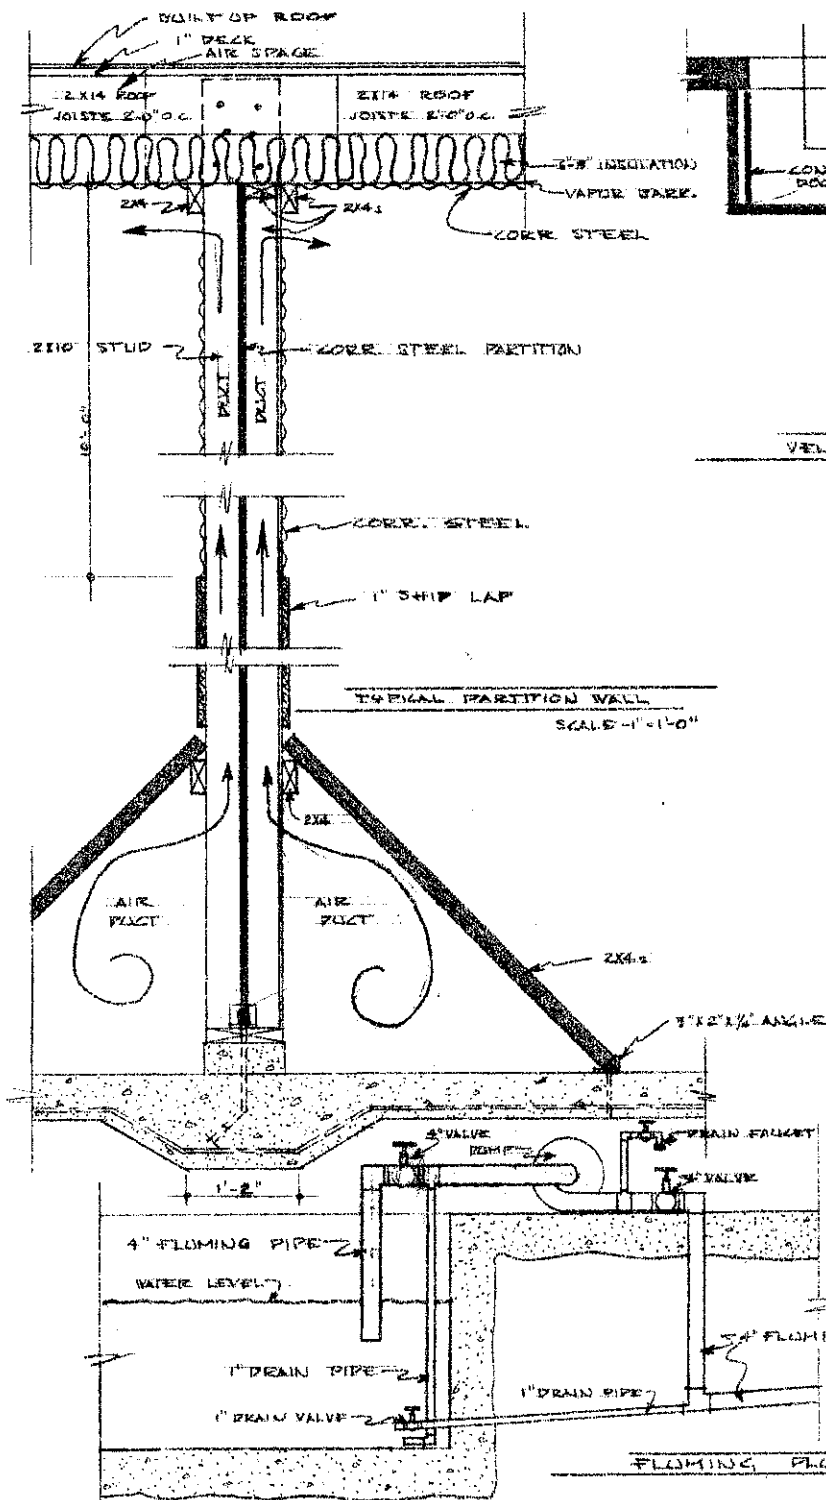

FLUMING PLUMBING SYSTEM  
NO SCALE

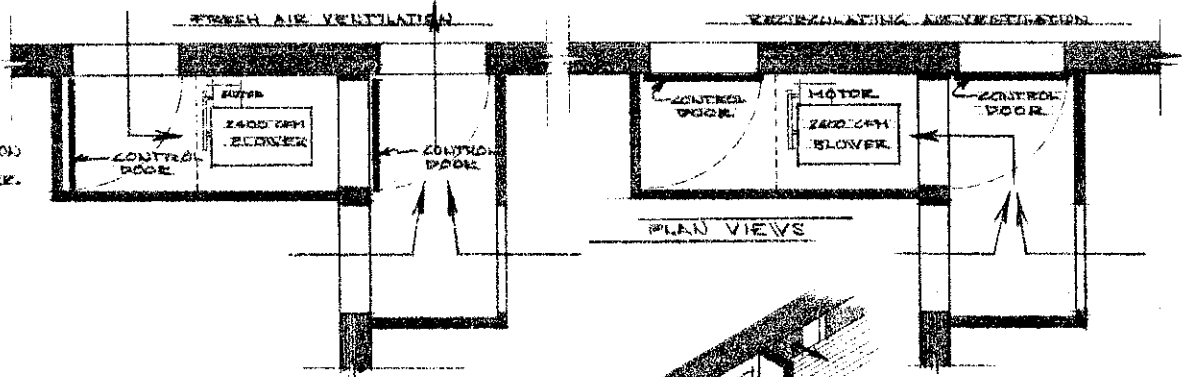

VENTILATION SYSTEM  
SCALE - 3/8" = 1'-0"

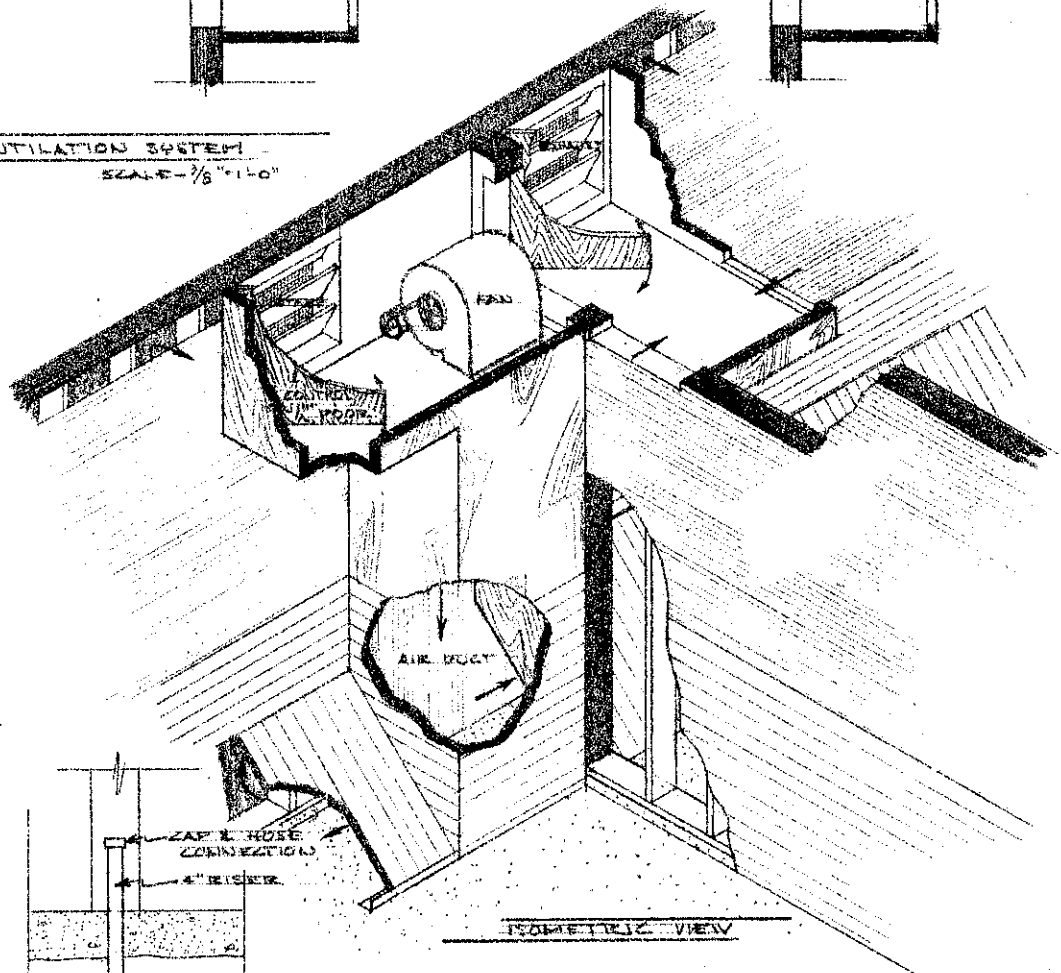

NOTE: THERE ARE THREE RISERS. LOCATIONS ARE SHOWN ON FLOOR PLAN.

100,000 BUSHEL POTATO WAREHOUSE	
MIDWEST PLAN SERVICE	
DESIGNED BY GEORGE L. FRAY AGRICULTURAL ENGINEERING DEPT. NORTH DAKOTA AGRICULTURAL COL.	
JULY 1936	SHEET 4-1-6
N.D. 734-6-4	